

ADDENDUM 1 RFP 2526-002 Culinary Classroom A&E

1) Question:

Will Food Service Consultant services be contracted directly by the New Milford Board of Education, or are they to be provided through the awarded A&E firm?

Answer:

Food Service Consultant services are to be provided through the awarded A&E firm. All costs associated with such consultations are to be included in the firm's lump-sum bid and incorporated as part of the overall scope of work.

2) Question:

Is the proposed room constructed as slab-on-grade?

Answer:

Based on available information and site observations, the room is understood to be slab-on-grade. Bidders should reference their site visit observations when preparing their proposals.

3) Question:

Is the roof above the classroom flat, and what is the nature of the space above the ceiling?

Answer:

Based on available information and site observations, the roof above the classroom is understood to be flat. The space above the ceiling grid is estimated to be approximately 4 feet, with trusses approximately 24 inches in height, and contains various mechanical systems. Bidders should reference their site visit observations when preparing their proposals.

4) Question:

What type of HVAC equipment currently supplies the space?

Answer:

Based on available information and site observations, the space is served by an air handler providing both heating and cooling, in conjunction with dedicated Variable Air Volume (VAV) units for that room. Bidders should reference their site visit observations when preparing their proposals.




5) Question:

Can the District provide any drawings of the space under consideration?


Answer:

Yes. This addendum includes several PDF drawings depicting the area under consideration. Some of these drawings are preliminary and not final as-builts. The room being considered is known as Exercise Room 159 on drawings. The New Milford Board of Education is not responsible for any discrepancies between these drawings and actual site conditions. Bidders should also reference their own observations from the site visit when preparing their proposals.

K:\49801\49801\DWG\PLUMB-FP\P101-4 4-4-98 11:55:46 am EST

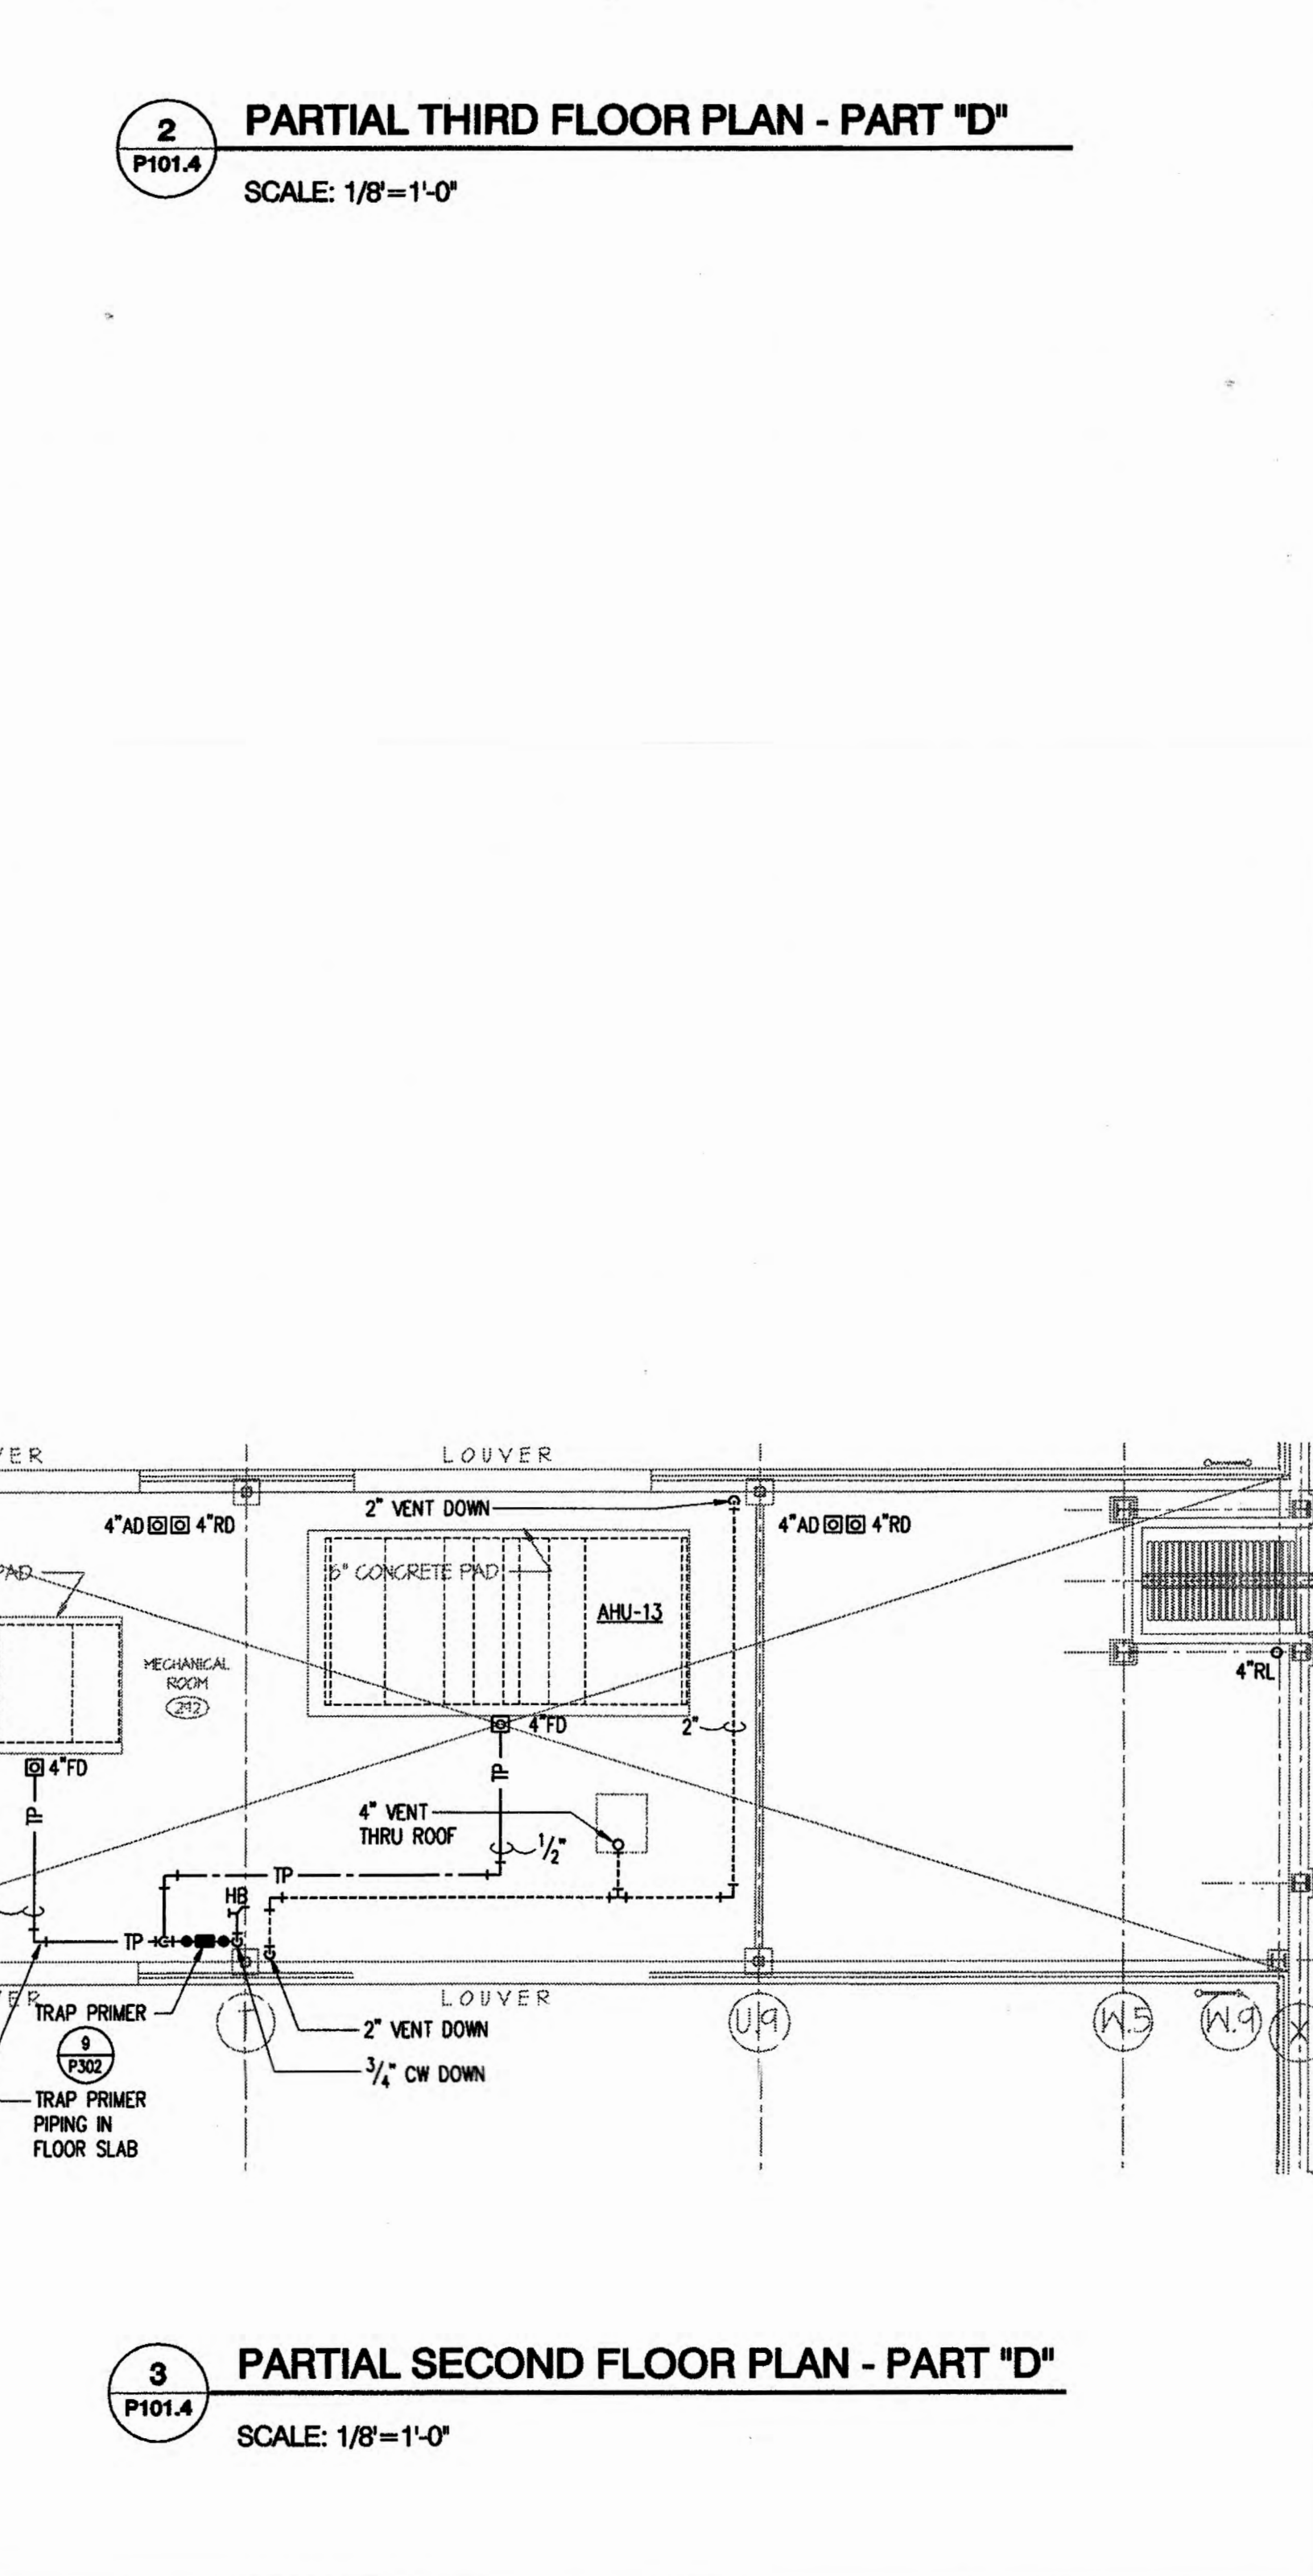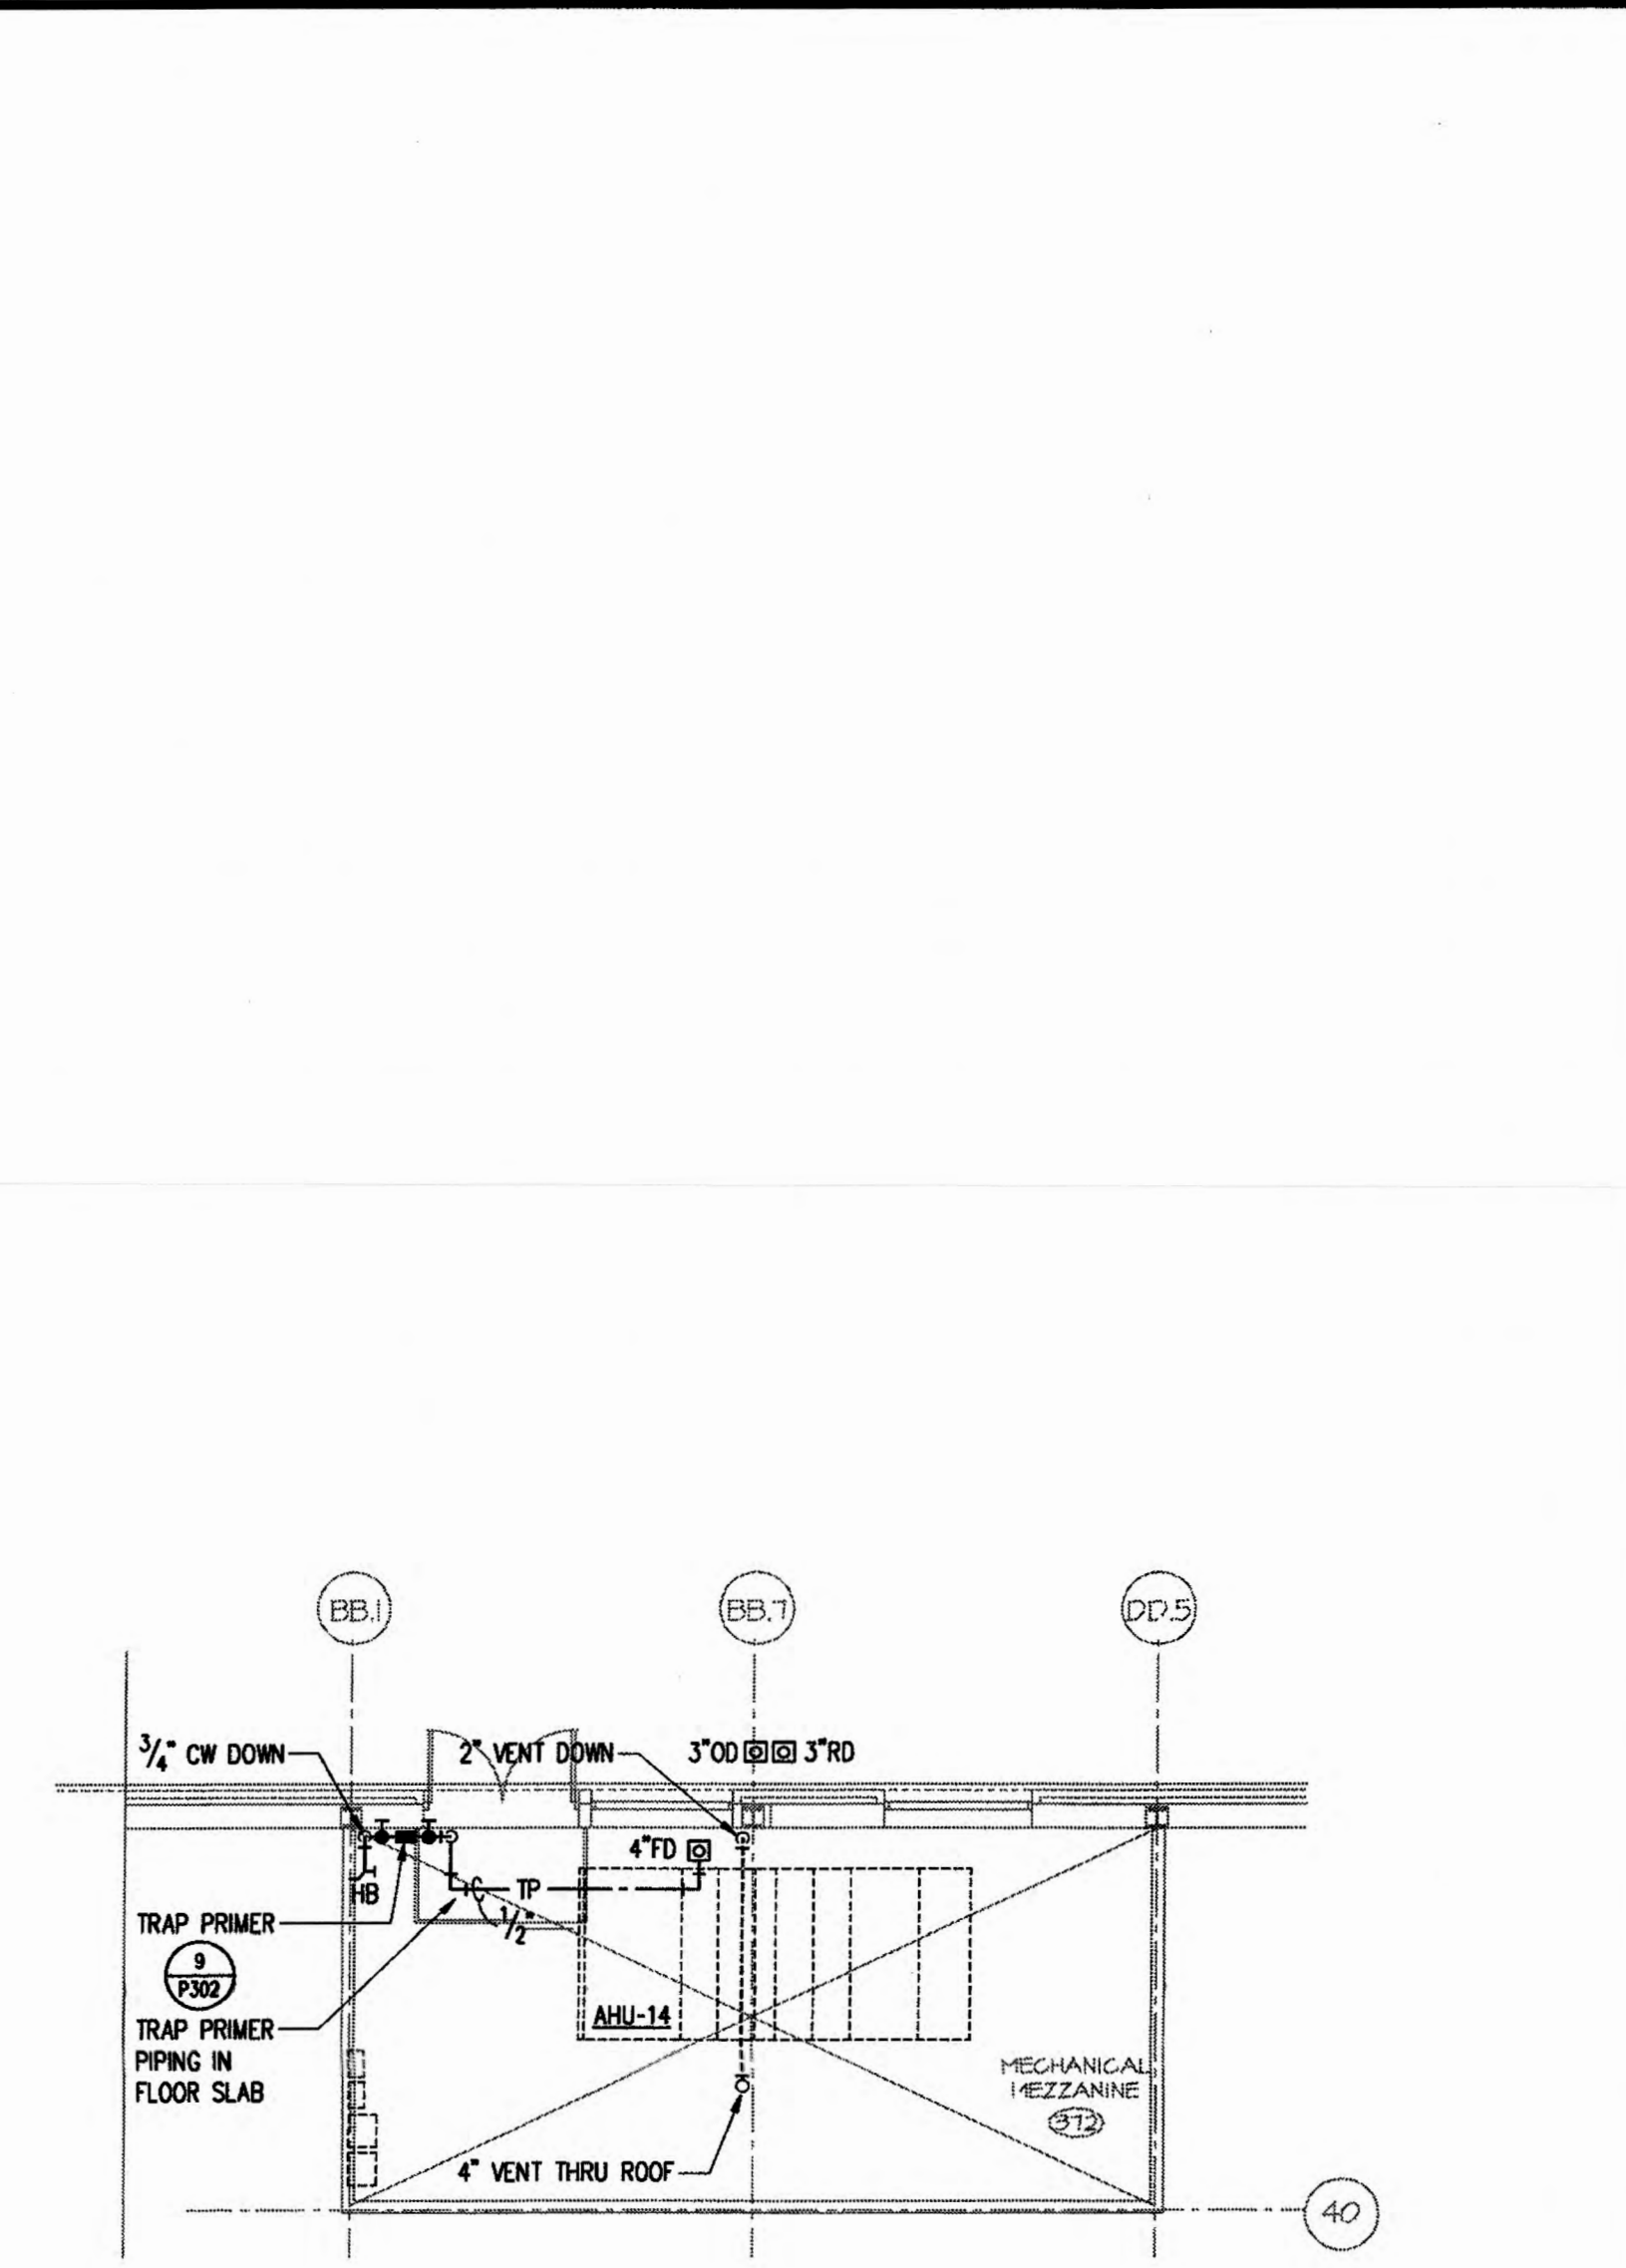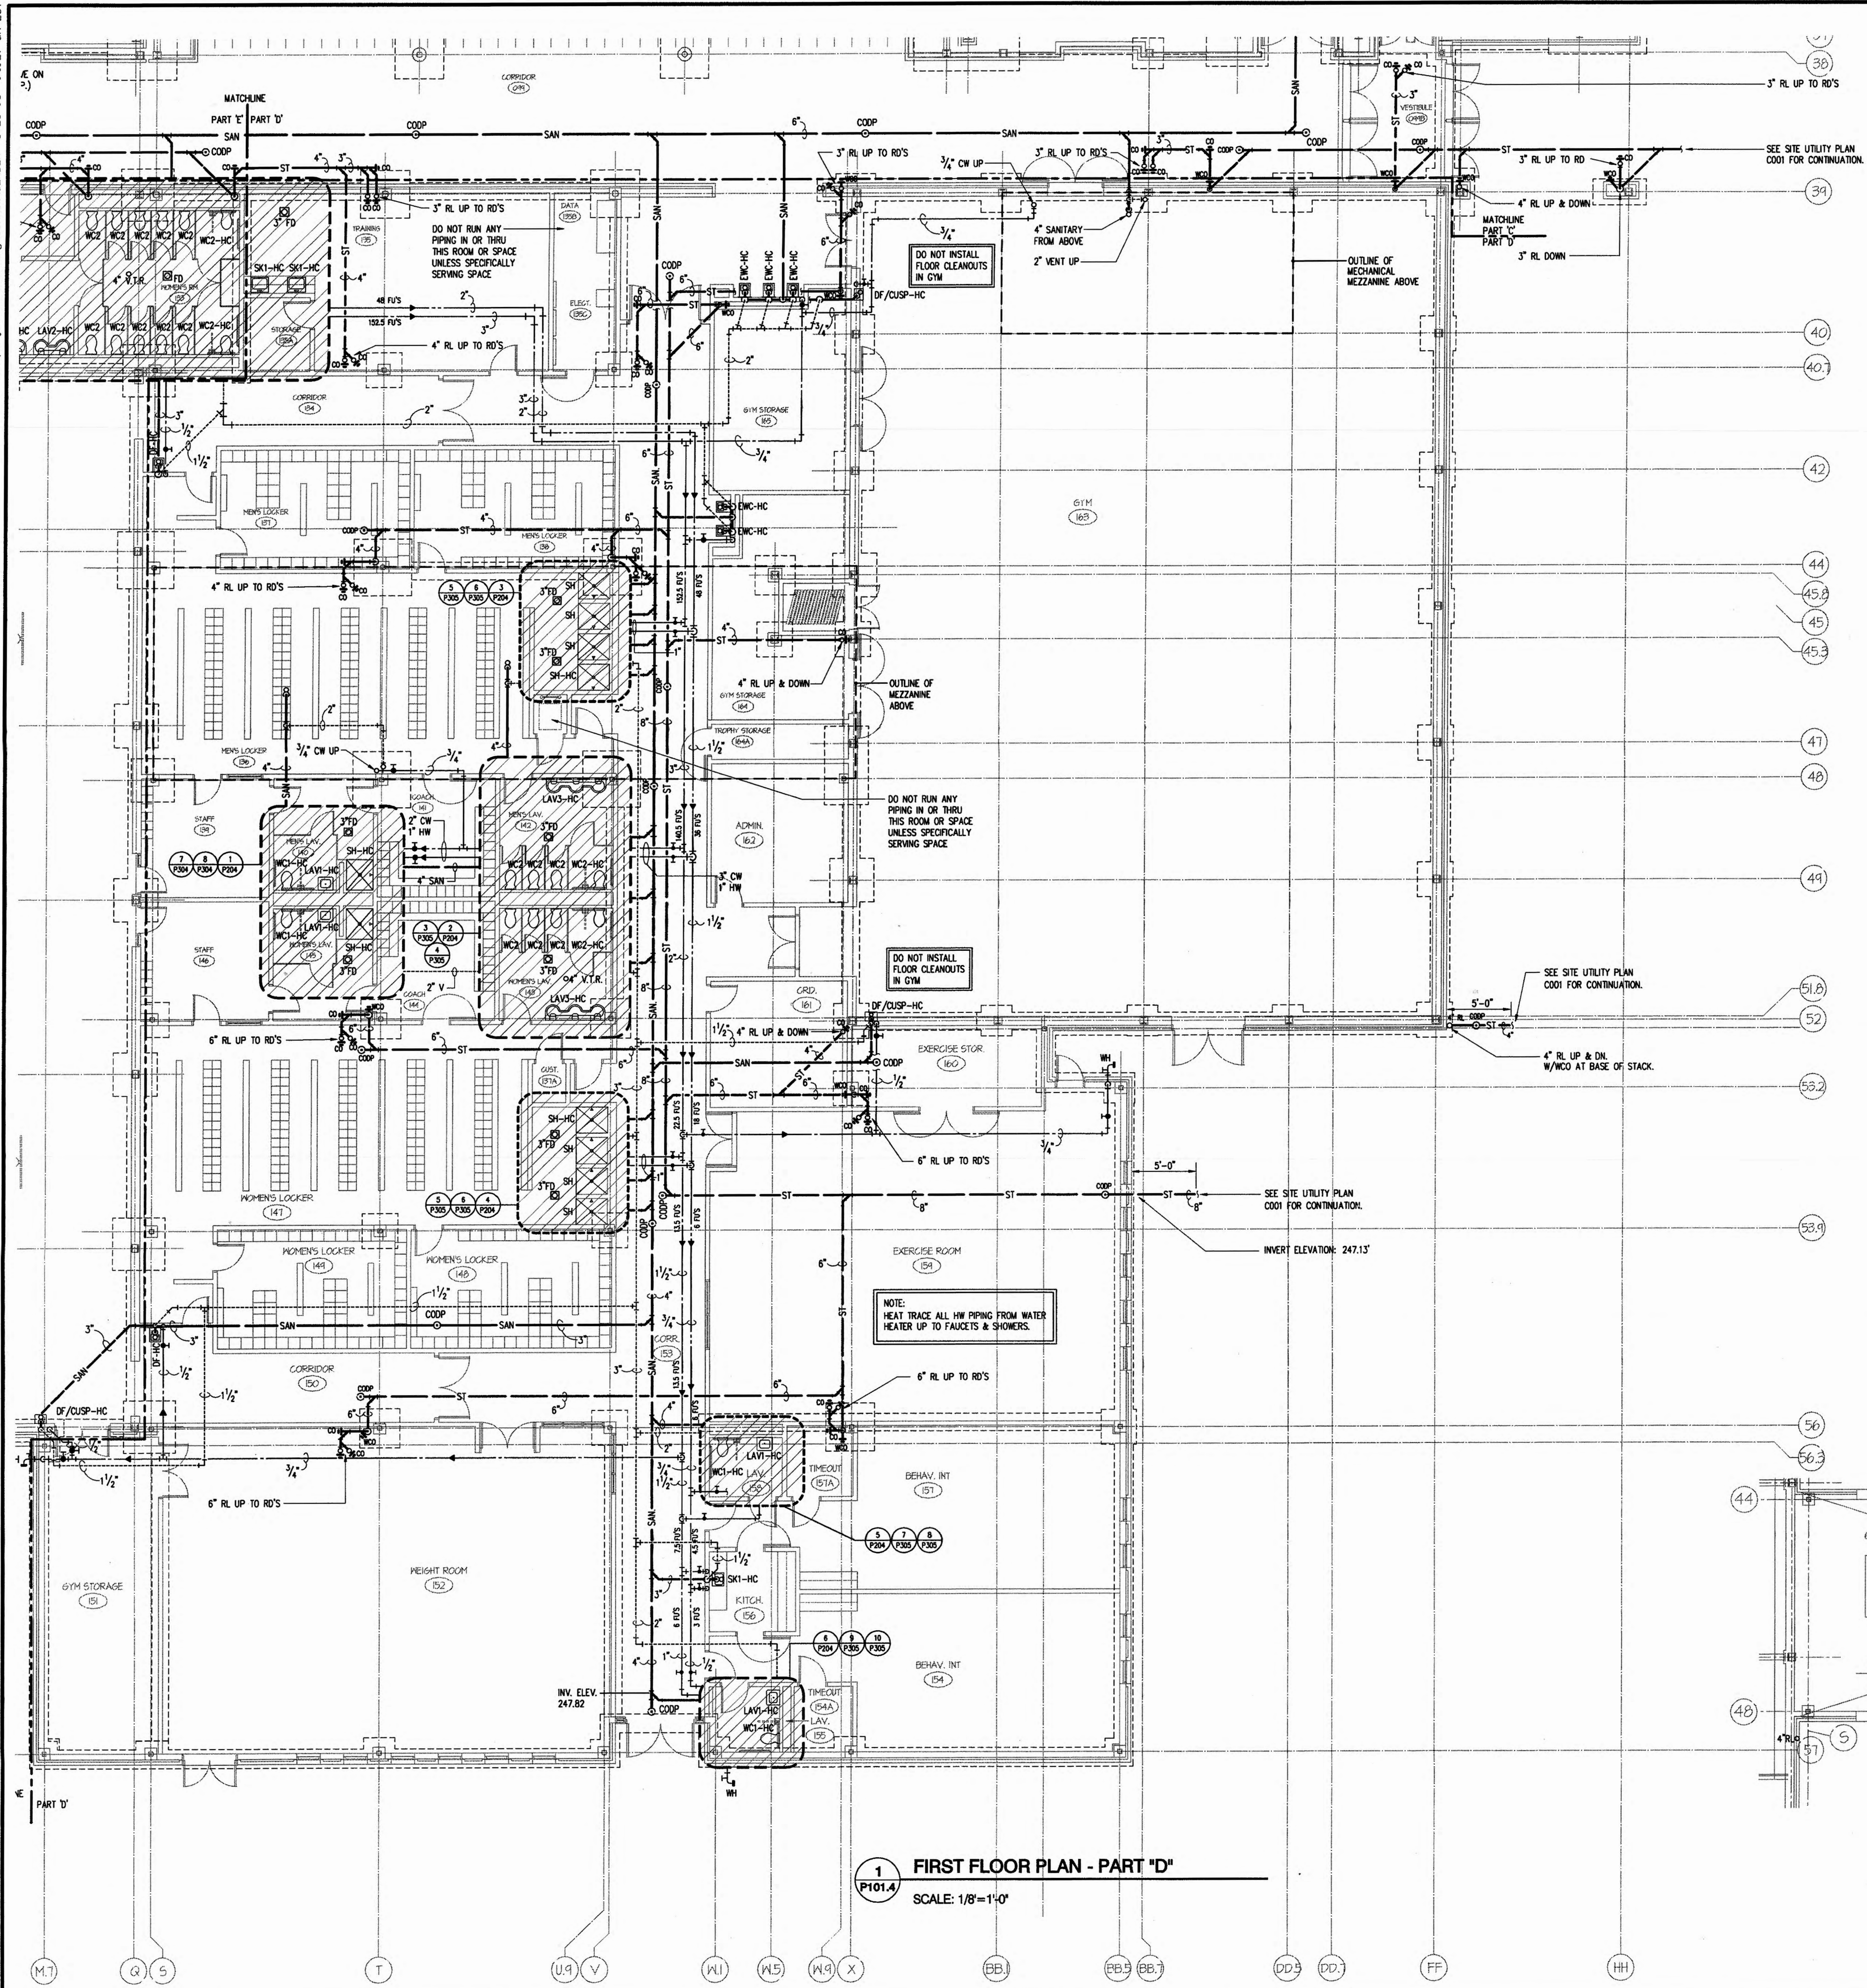

This drawing and details on it, as an instrument of service, is the property of the architect and may be used for this specific project and shall not be loaned, copied or reproduced without written consent of the architect.

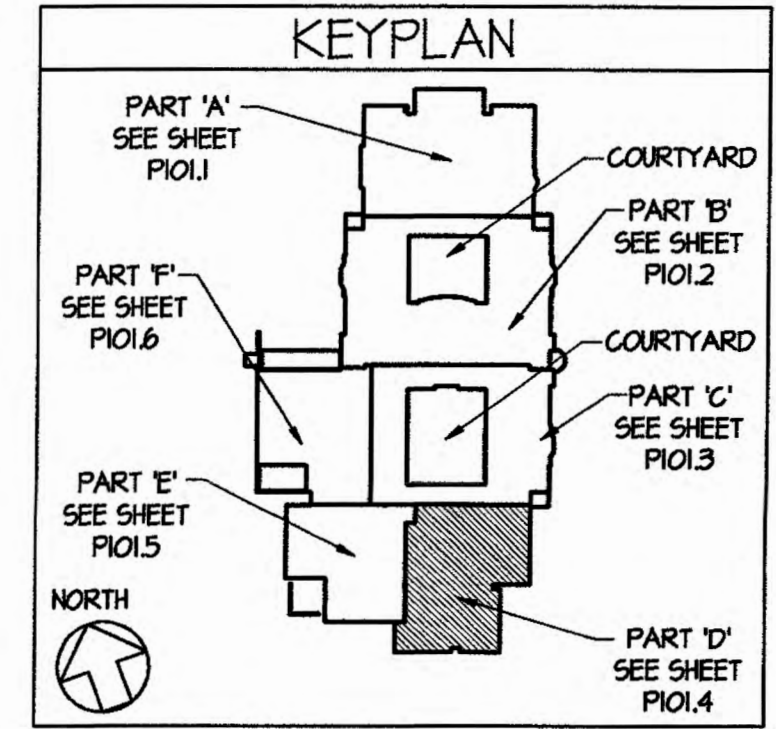

- PLUMBING PLAN NOTES:
1. REFER TO DRAWING P401 FOR PLUMBING NOTES PERTAINING TO THIS AND ALL PLUMBING DRAWINGS.
 2. REFER TO DRAWING P401 FOR SYMBOL LIST AND LIST OF ABBREVIATIONS FOR THESE PLUMBING DRAWINGS.
 3. REFER TO DRAWING P401 FOR ACCESSIBILITY PLUMBING FIXTURE SCHEDULE FOR THESE PLUMBING DRAWINGS.

PROJECT MANAGER	J. COSTA
PROJECT DESIGNER	J. SELLS
ARCHITECT/ENGINEER	J. STENQVIST
DRAWN BY	R. DECARLOS

FLETCHER THOMPSON
ARCHITECTURE / ENGINEERING / INTERIOR DESIGN

FLETCHER-THOMPSON, INC.
TWO LAFAYETTE SQUARE
BRIDGEPORT, CT 06604-3944

NEW MILFORD HIGH SCHOOL
LARSON FARM
NEW MILFORD, CT

STATE PROJECT NO. 096-032N

FIRST FLOOR PLAN - PART "D" PLUMBING

SCALE: 1/8" = 1'-0"


SEPTEMBER 8, 1998

SCALE: 1/8" = 1'-0"

PROJECT NO. 49801.06

DRAWING NO. **P101.4**

K:\49 projects\49801\DWG\Fire-PP101-4 9-9-98 10:11:30 am EST

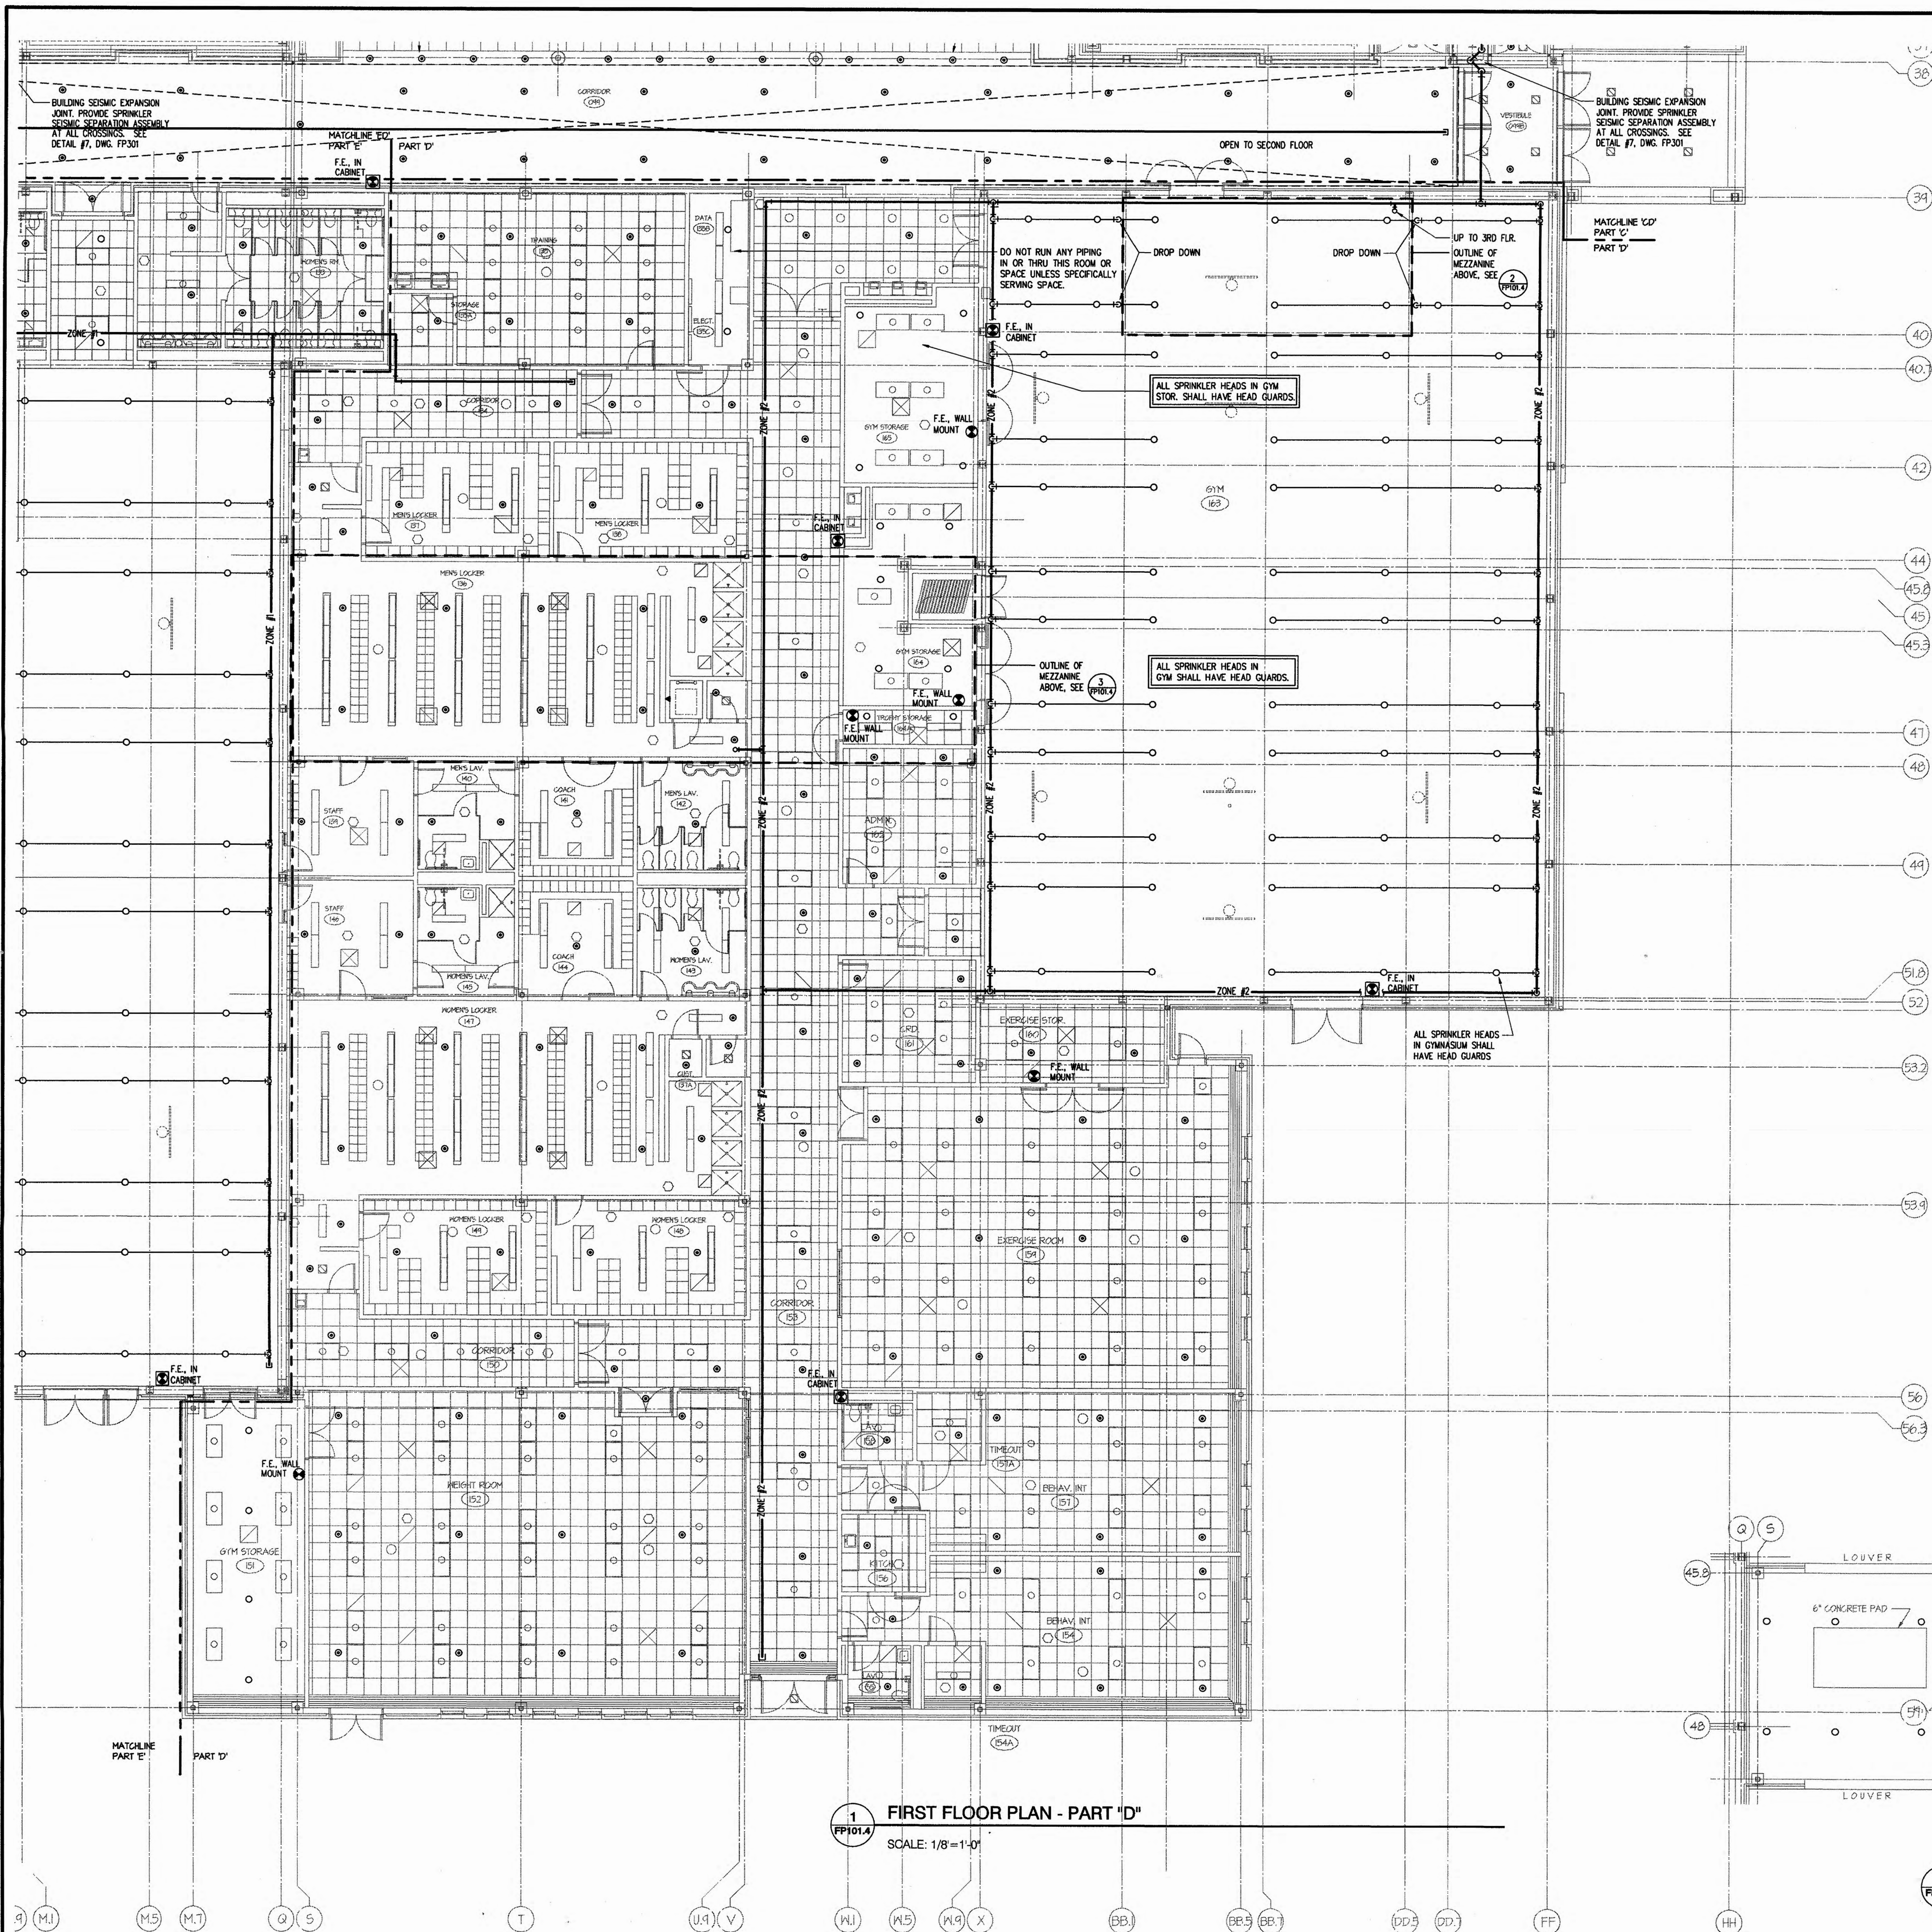


1 FIRST FLOOR PLAN - PART "D"
SCALE: 1/8"=1'-0"


2 PARTIAL THIRD FLOOR PLAN - PART "D"
SCALE: 1/8"=1'-0"

3 PARTIAL SECOND FLOOR PLAN - PART "D"
SCALE: 1/8"=1'-0"

This drawing and details on it, as an instrument of service, is the property of the architect and may be used for this specific project and shall not be loaned, copied or reproduced without written consent of the architect.

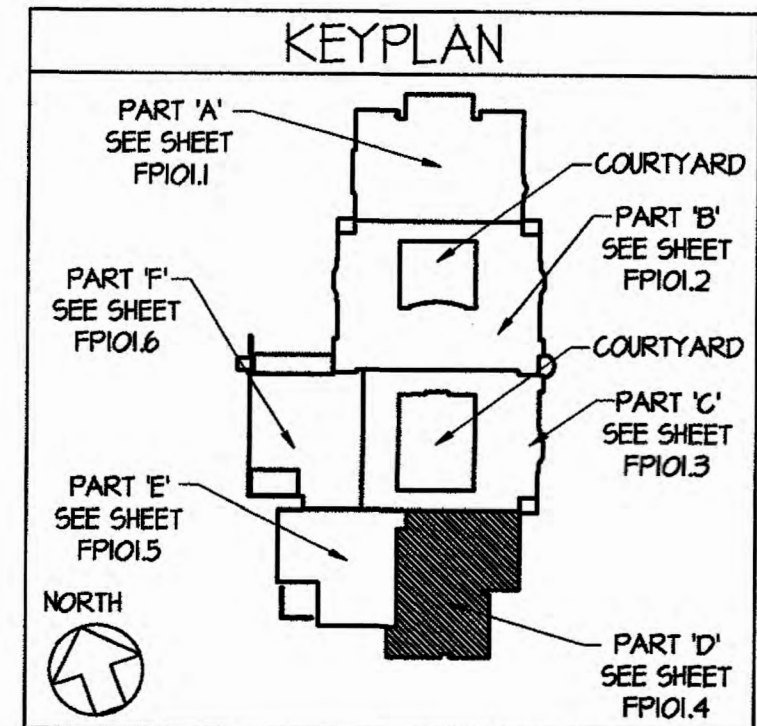

- FIRE PROTECTION PLAN NOTES:
- REFER TO DRAWING FP101 FOR FIRE PROTECTION NOTES PERTAINING TO THIS AND ALL FIRE PROTECTION DRAWINGS.
 - REFER TO DRAWING FP101 FOR SYMBOL LIST AND LIST OF ABBREVIATIONS FOR THESE FIRE PROTECTION DRAWINGS.

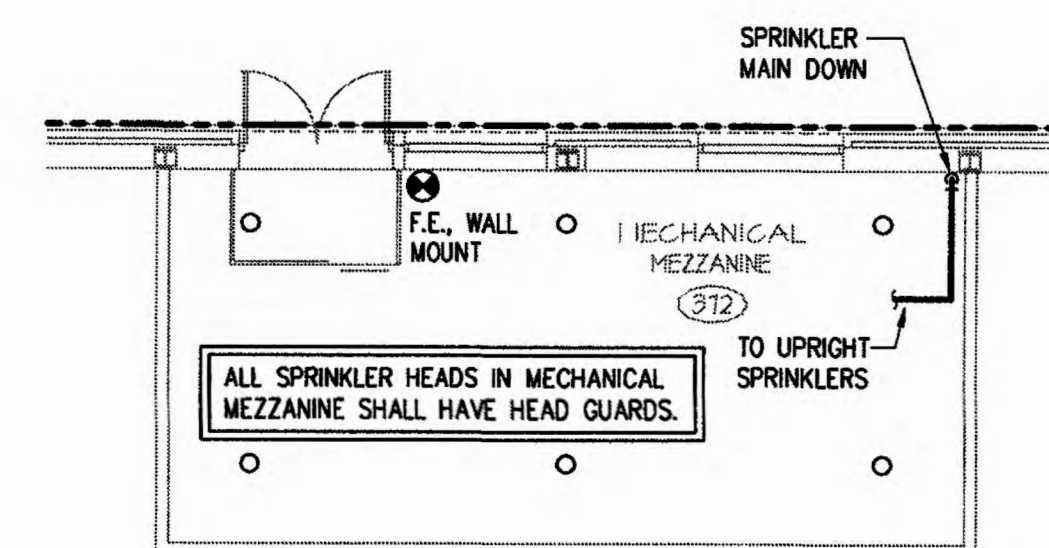

PROFESSIONAL SEAL

PROJECT MANAGER J. COSTA
PROJECT DESIGNER J. SELLS
ARCHITECT/ENGINEER J. STENQVIST
DRAWN BY R. DECARLO/SLF



FLETCHER
THOMPSON

ARCHITECTURE/ENGINEERING/INTERIOR DESIGN

FLETCHER-THOMPSON, INC.
TWO LAFAYETTE SQUARE
BRIDGEPORT, CT 06604-3944

PROJECT TITLE

NEW MILFORD
HIGH SCHOOL
LARSON FARM
NEW MILFORD, CT

STATE PROJECT NO. 096-032N

DRAWING TITLE

FIRST FLOOR
PLAN - PART "D"
FIRE PROTECTION

0 4' 8' 16'
SCALE: 1/8" = 1'-0"

NO DATE REVISION BY


DATE SEPTEMBER 8, 1998

SCALE 1/8"=1'-0"

PROJECT NO. 49801.06

DRAWING NO. FP101.4

K:\49 projects\49801\DWG\Fire-PP101-4 9-9-98 10:11:30 am EST

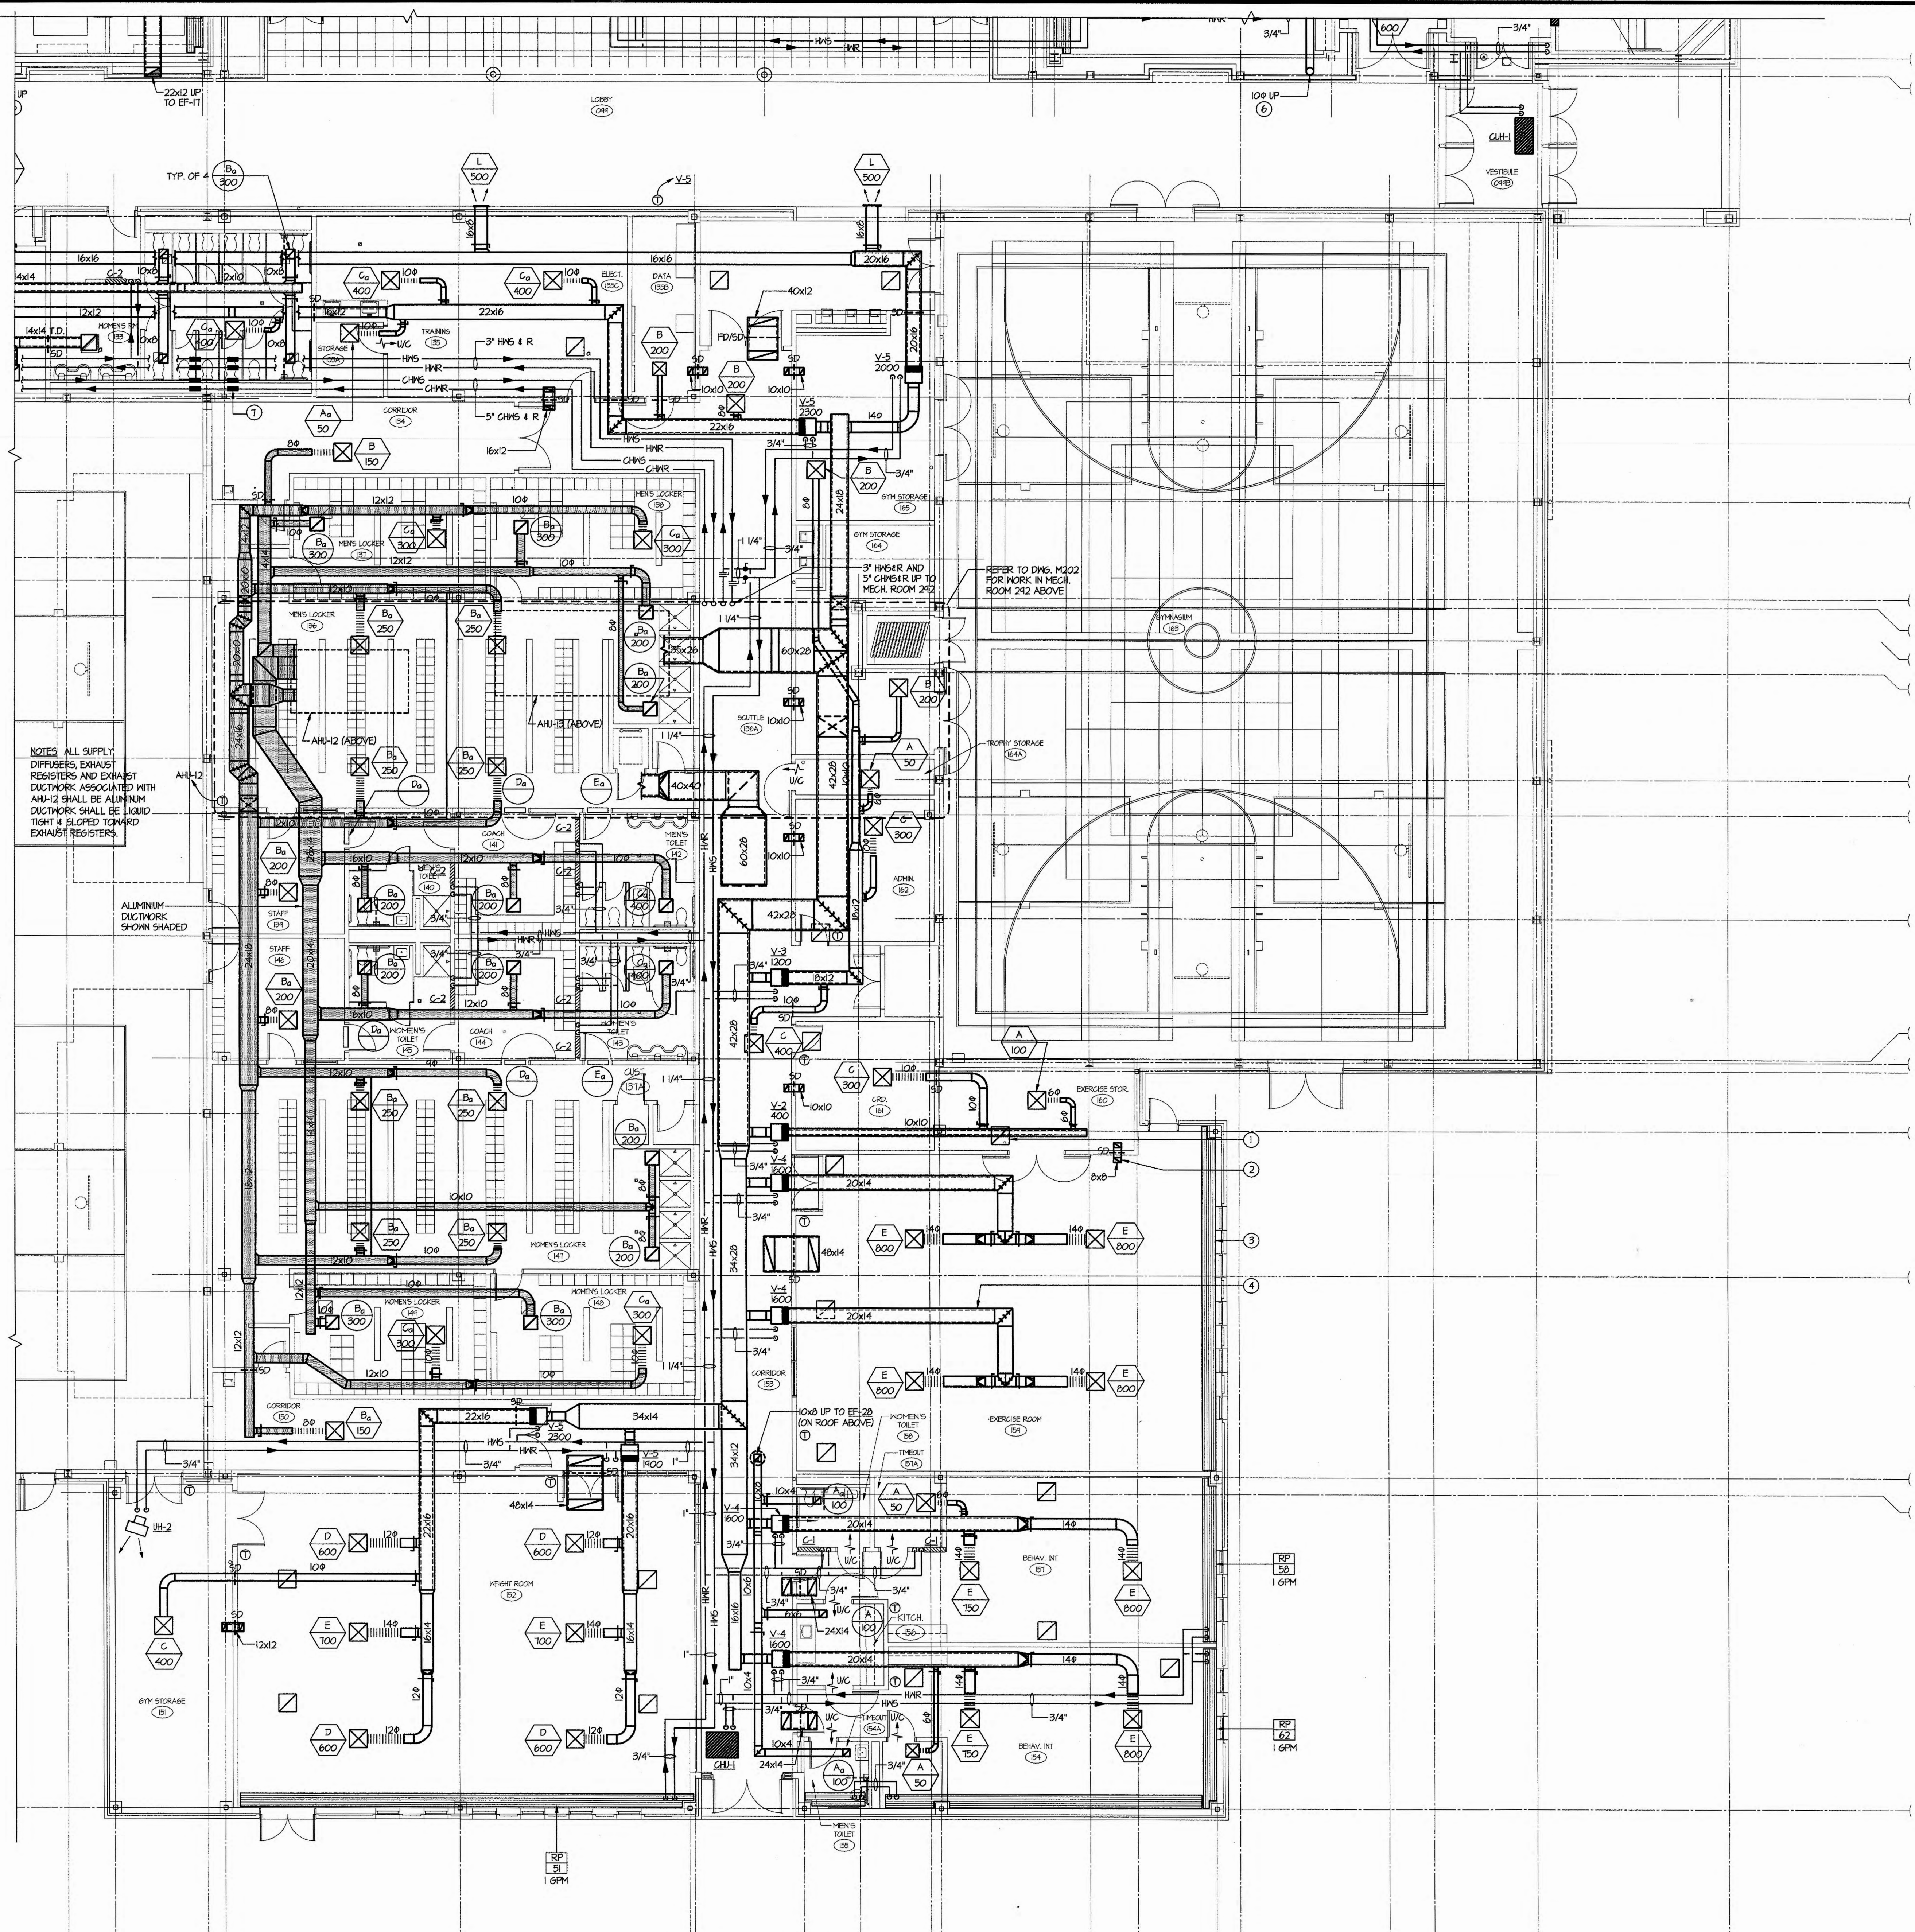


NOTES: ALL SUPPLY DIFFUSERS, EXHAUST REGISTERS AND EXHAUST DUCTWORK ASSOCIATED WITH AHU-12 SHALL BE ALUMINUM. DUCTWORK SHALL BE LIQUID TIGHT & SLOPED TOWARD EXHAUST REGISTERS.

ALUMINUM DUCTWORK SHOWN SHADED

1 FIRST FLOOR PLAN - PART "D"
SCALE: 1/8" = 1'-0"

This drawing and details on it, as an instrument of service, is the property of the architect and may be used for this specific project and shall not be loaned, copied or reproduced without written consent of the architect.

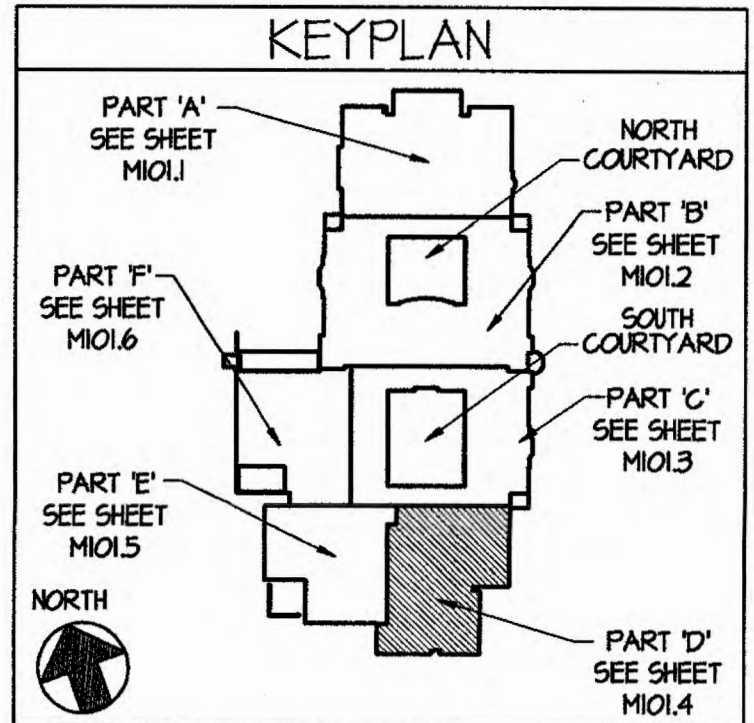

- GENERAL NOTES:
1. REFER TO DRAWINGS ME401, ME402 AND ME403 FOR HVAC SCHEDULES
 2. REFER TO DRAWINGS ME403 FOR SYMBOL LIST AND LIST OF ABBREVIATIONS.
 3. PROVIDE CONTROL ON EACH HW BRANCH FEED TO RADIANT PANEL.
 4. REFER TO DWGS. M301 & 302 FOR EQUIPMENT, PIPING AND DUCTWORK DETAILS.
- KEY PLAN NOTES:
1. RETURN GRILLE (TYP) REFER TO DIFFUSER, REGISTER & GRILLE SCHEDULE ON DWG. ME403.
 2. TRANSFER DUCT (TYP) REFER TO DETAIL II ON DWG. M302
 3. RADIANT CEILING PANEL, RUN PANEL WALL TO HALL OR COLUMN TO COLUMN. CUT OUT PANEL FOR COLUMN ENCLOSURES, REFER TO DETAIL 14 ON M302 FOR PIPING ARRANGEMENT & INSTALLATION DETAILS.
 4. INTERNAL LINING ON DUCTWORK SHALL BE EQUAL TO "MANVILLE" LINACUSTIC R-300, RIGID FIBERGLASS DUCT LINER ASTM D2071, 621 AND 622 1" THICK.
 5. 18 GAUGE 316 STAINLESS STEEL DUCT WELDED, LIQUID TIGHT
 6. ALUMINUM DRYER EXHAUST DUCT SMOOTH INSIDE 50 AS NOT TO CATCH LINT. PROVIDE CLEANOUT AT DRYER.
 7. SEISMIC EXPANSION JOINT "MASON" HINGED TYPE. REFER TO DETAIL 9 ON DWG. M302.
 8. LINED DUCTWORK IN SHAFT.
 9. MOTORIZED EXHAUST AIR VALVES (PHOENIX) FOR FUME HOOD & GENERAL ROOM EXHAUST.

PROFESSIONAL SEAL

PROJECT MANAGER J. COSTA
PROJECT DESIGNER J. SELLS
ARCHITECT/ENGINEER J. GREENSPUN
DRAWN BY D. EAR



FLETCHER THOMPSON

ARCHITECTURE / ENGINEERING / INTERIOR DESIGN

FLETCHER-THOMPSON, INC.
TWO LAFAYETTE SQUARE
BRIDGEPORT, CT 06604-3944

PROJECT TITLE

NEW MILFORD
HIGH SCHOOL
LARSON FARM
NEW MILFORD, CT


STATE PROJECT NO. 096-032N

DRAWING TITLE

FIRST FLOOR
PLAN - PART "D"
- HVAC


0 4' 8' 16'
SCALE: 1/8" = 1'-0"

NO DATE REVISION BY
DATE
SEPTEMBER 8, 1998
SCALE 1/8" = 1'-0"
PROJECT NO. 49801.06
DRAWING NO. M101.4

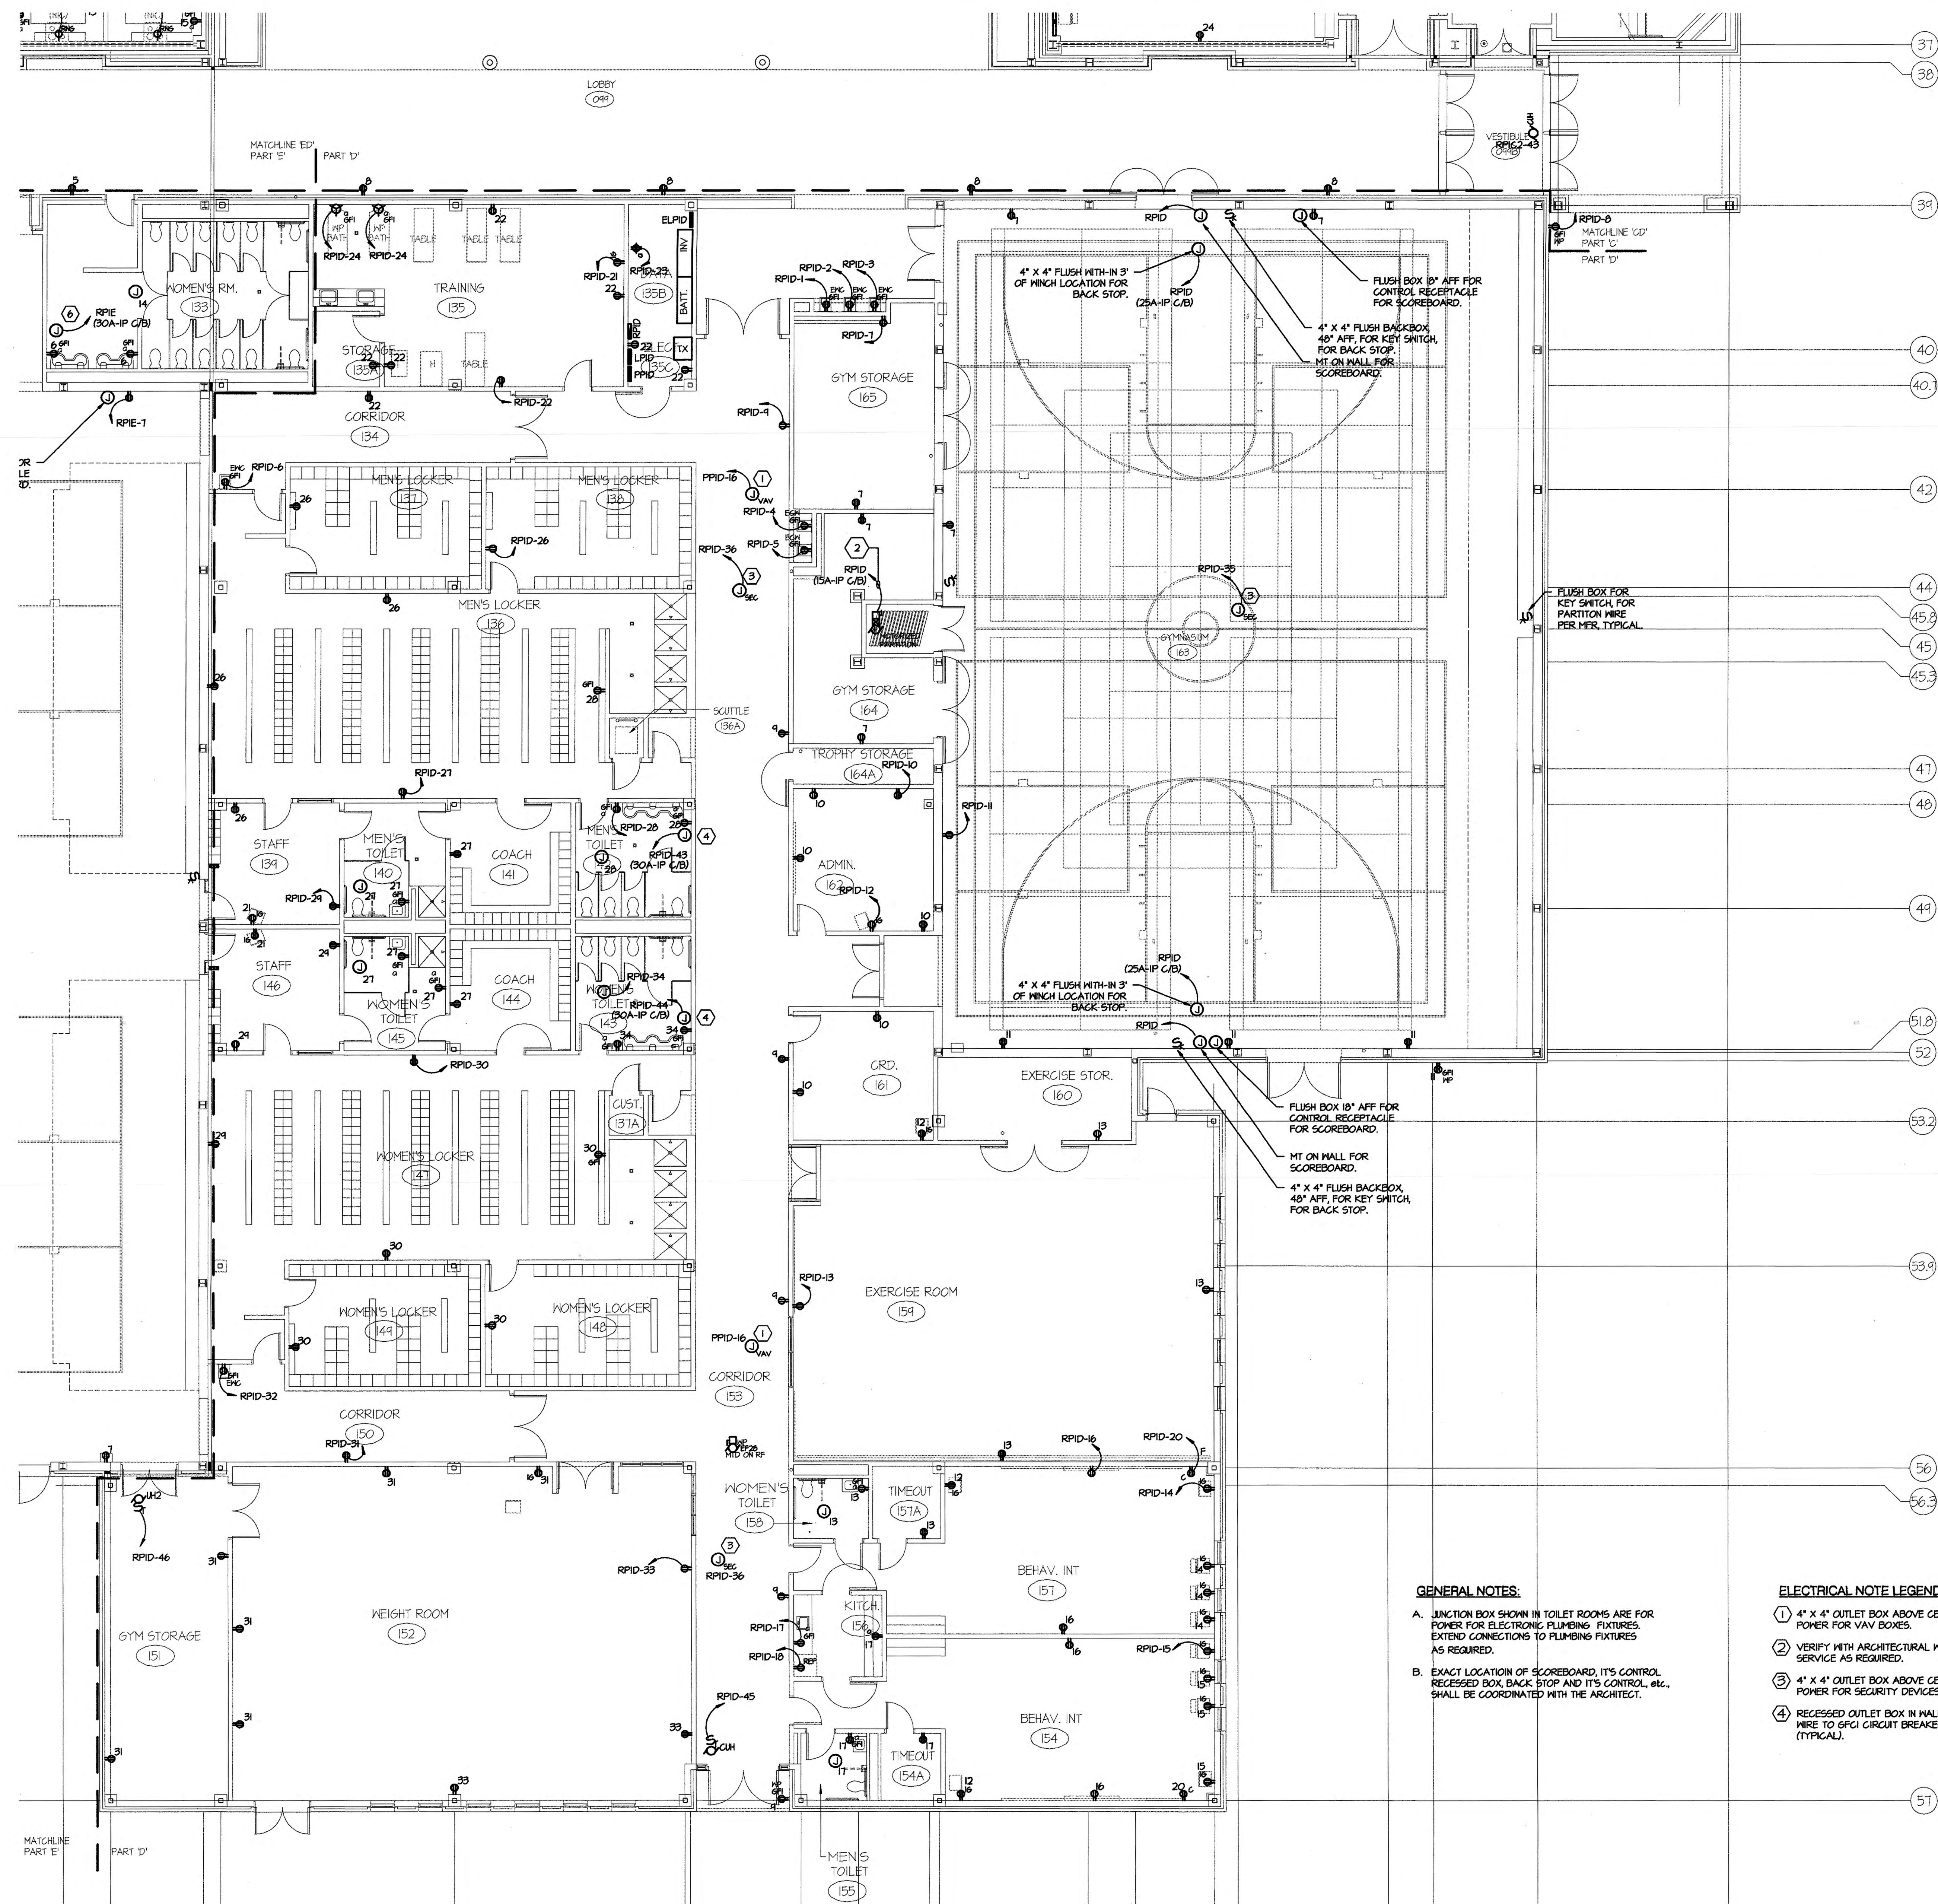

1
K101.4
FIRST FLOOR PLAN - PART "D"
SCALE: 1/8" = 1'-0"

This drawing and details on it, as an instrument of service, is the property of the architect and may be used for this specific project and shall not be loaned, copied or reproduced without written consent of the architect.

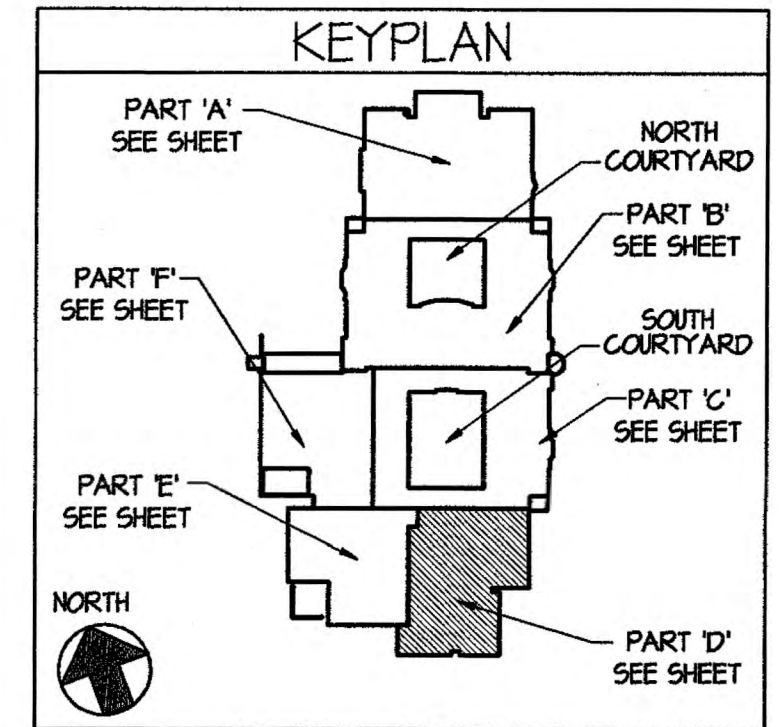

ELECTRICAL PLAN NOTES:
1. REFER TO DRAWING E401 FOR ELECTRICAL NOTES PERTAINING TO THIS AND ALL ELECTRICAL DRAWINGS.
2. REFER TO DRAWING E401 FOR SYMBOL LIST AND LIST OF ABBREVIATIONS FOR THESE ELECTRICAL DRAWINGS.

PROFESSIONAL SEAL

PROJECT MANAGER J. COSTA
PROJECT DESIGNER J. SELLS
ARCHITECT/ENGINEER R. BULSARA
DRAWN BY F. AGOSTINI



FLETCHER
THOMPSON

ARCHITECTURE / ENGINEERING / INTERIOR DESIGN

FLETCHER-THOMPSON, INC.
TWO LAFAYETTE SQUARE
BRIDGEPORT, CT 06604-3944

PROJECT TITLE

NEW MILFORD
HIGH SCHOOL
LARSON FARM
NEW MILFORD, CT

STATE PROJECT NO. 096-032N

DRAWING TITLE

FIRST FLOOR
- PART "D"
POWER
PLAN

0 4' 8' 16'
SCALE: 1/8" = 1'-0"

NO DATE REVISION BY

SEPTEMBER 8, 1998

SCALE 1/8" = 1'-0"

PROJECT NO. 49801.06

DRAWING NO. E101.4

